


1 BLACK BOX THEATER GROUNDPLAN  
1/4" = 1'-0"

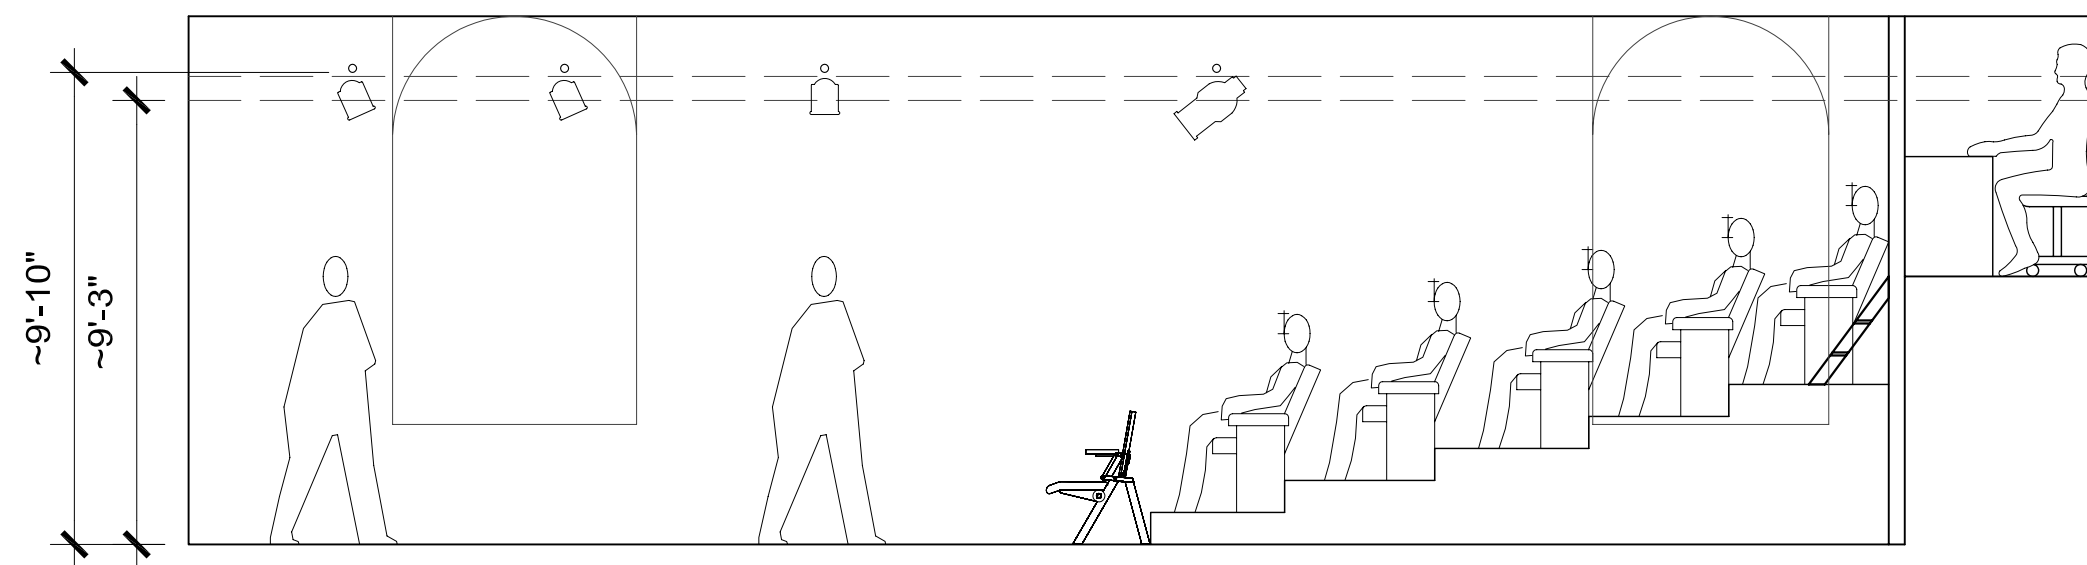

2 BLACK BOX THEATER STAGE SECTION  
1/4" = 1'-0"

HATCH KEY:		ELECTRICAL SCHEDULE:					NOTES:		ACCESS THEATER - BLACK BOX THEATER	
	WALL	RECEPTACLE	RATING	MOUNTING	PURPOSE	FED FROM PANEL	1. 50 FIXED SEAT, 10 LOOSE SEATS ADDITIONAL. (74) PERSON LIMIT INCLUDING AUDIENCE AND ALL PRODUCTION STAFF. NO STANDING ROOM ALLOWED 2. 3'-0" CLEAR PATH IS TO BE MAINTAINED BETWEEN SEATING UNITS AND BACKSTAGE EXIT 3. NO MATERIALS MAY BE STORED IN THE BACKSTAGE BATHROOM, LOCATIONS HATCHED "ACCESS THEATER USE ONLY" OR LOCATIONS HATCHED "CLEAR AREA" 4. ALL DIMENSIONING IS TO A TOLERANCE OF +/-6", FIELD VERIFY ALL TIGHT MEASUREMENTS BEFORE LOAD-IN.	TITLE: COMPREHENSIVE GROUNDPLAN AND STAGE SECTION		SHEET NUMBER: <b>BB1</b>
	CLEAR AREA	1	20AMP @ 120V	PIPE #1	DIMMERS 1-4	BOOTH PANEL		SCALE: 1/4" = 1'-0"		
	ACCESS THEATER USE ONLY	2	20AMP @ 120V	PIPE #2	DIMMERS 5-8	BOOTH PANEL		REVISED ON: JANUARY 28, 2004	DRAWN BY: MFE	
		3	20AMP @ 120V	PIPE #3	DIMMERS 9-12	BOOTH PANEL		PLEASE NOTE: NO CABLING, SCENERY OR OTHER PRODUCTION EQUIPMENT MAY BE DRAPED, ATTACHED OR RUN ALONG ANY SERVICE PIPES INCLUDING: GAS, SPRINKLER AND SEWER AT ANY TIME. NO EXCEPTIONS		
		4	20AMP @ 120V	PIPE #4	DIMMERS 13-16	BOOTH PANEL				
		5	15AMP @ 120V	WALL	BOOTH POWER	MAIN PANEL				
		6	20AMP @ 240V	WALL	AIR CONDITIONER	BOOTH PANEL				
		7	15AMP @ 120V	WALL	GEN. PURPOSE	MAIN PANEL				
		8	LOOPED WITH REC. #7		DRESSING ROOM	MAIN PANEL				
		9	LOOPED WITH REC. #7		DRESSING ROOM	MAIN PANEL				